


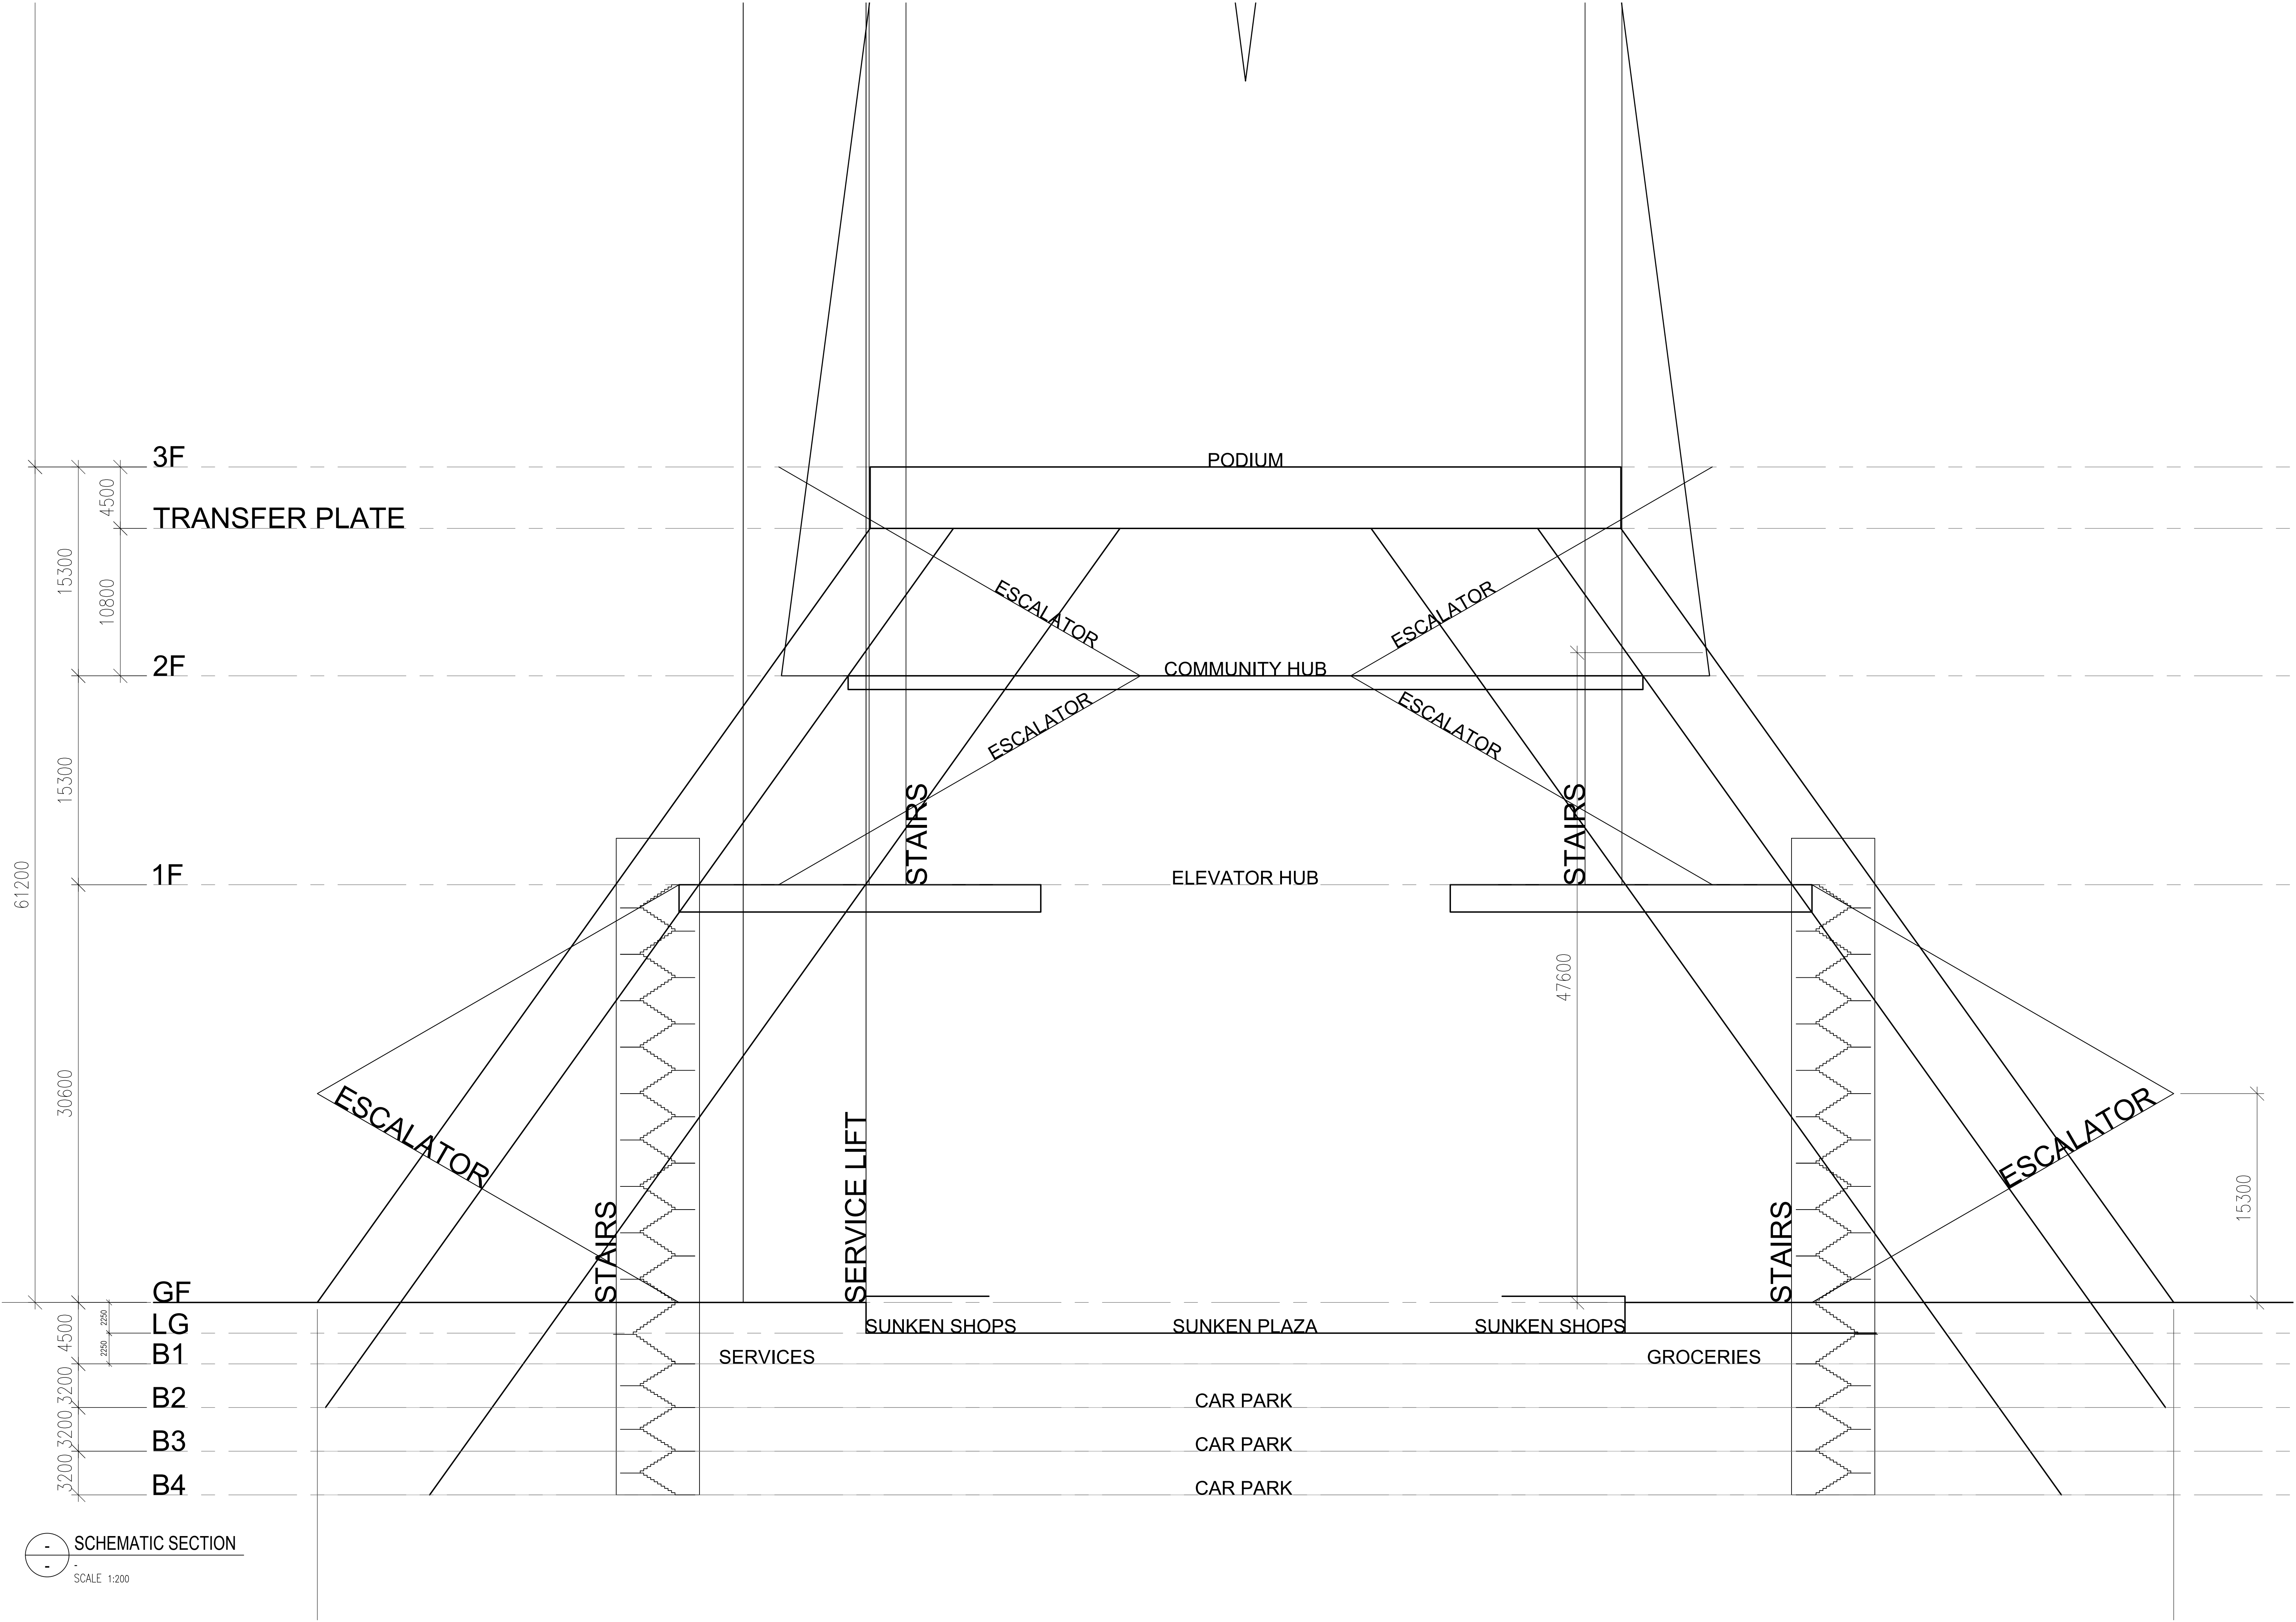


REFUSE CHAMBER
BULK WASTE
RECYCLING CENTRE
LOADING BAYS


TNB SSU PODIUM
TNB SSU T1 - T4
TNB METER ROOM



MDF ROOM
CONTROL ROOM
JANITOR ROOM
TOILETS

OSD PUMP ROOM
OSD TANK
RWHT PUMP ROOM
RWH TANK
SUCTION TANK PUMP ROOM
SUNCTION TANK
FIRE PUMP ROOM
WET RISER TANK
HOSE REEL TANK

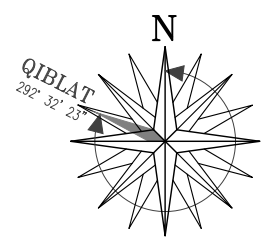


-1 BASEMENT 1 PLAN
SERVICE LEVEL
SCALE 1:300

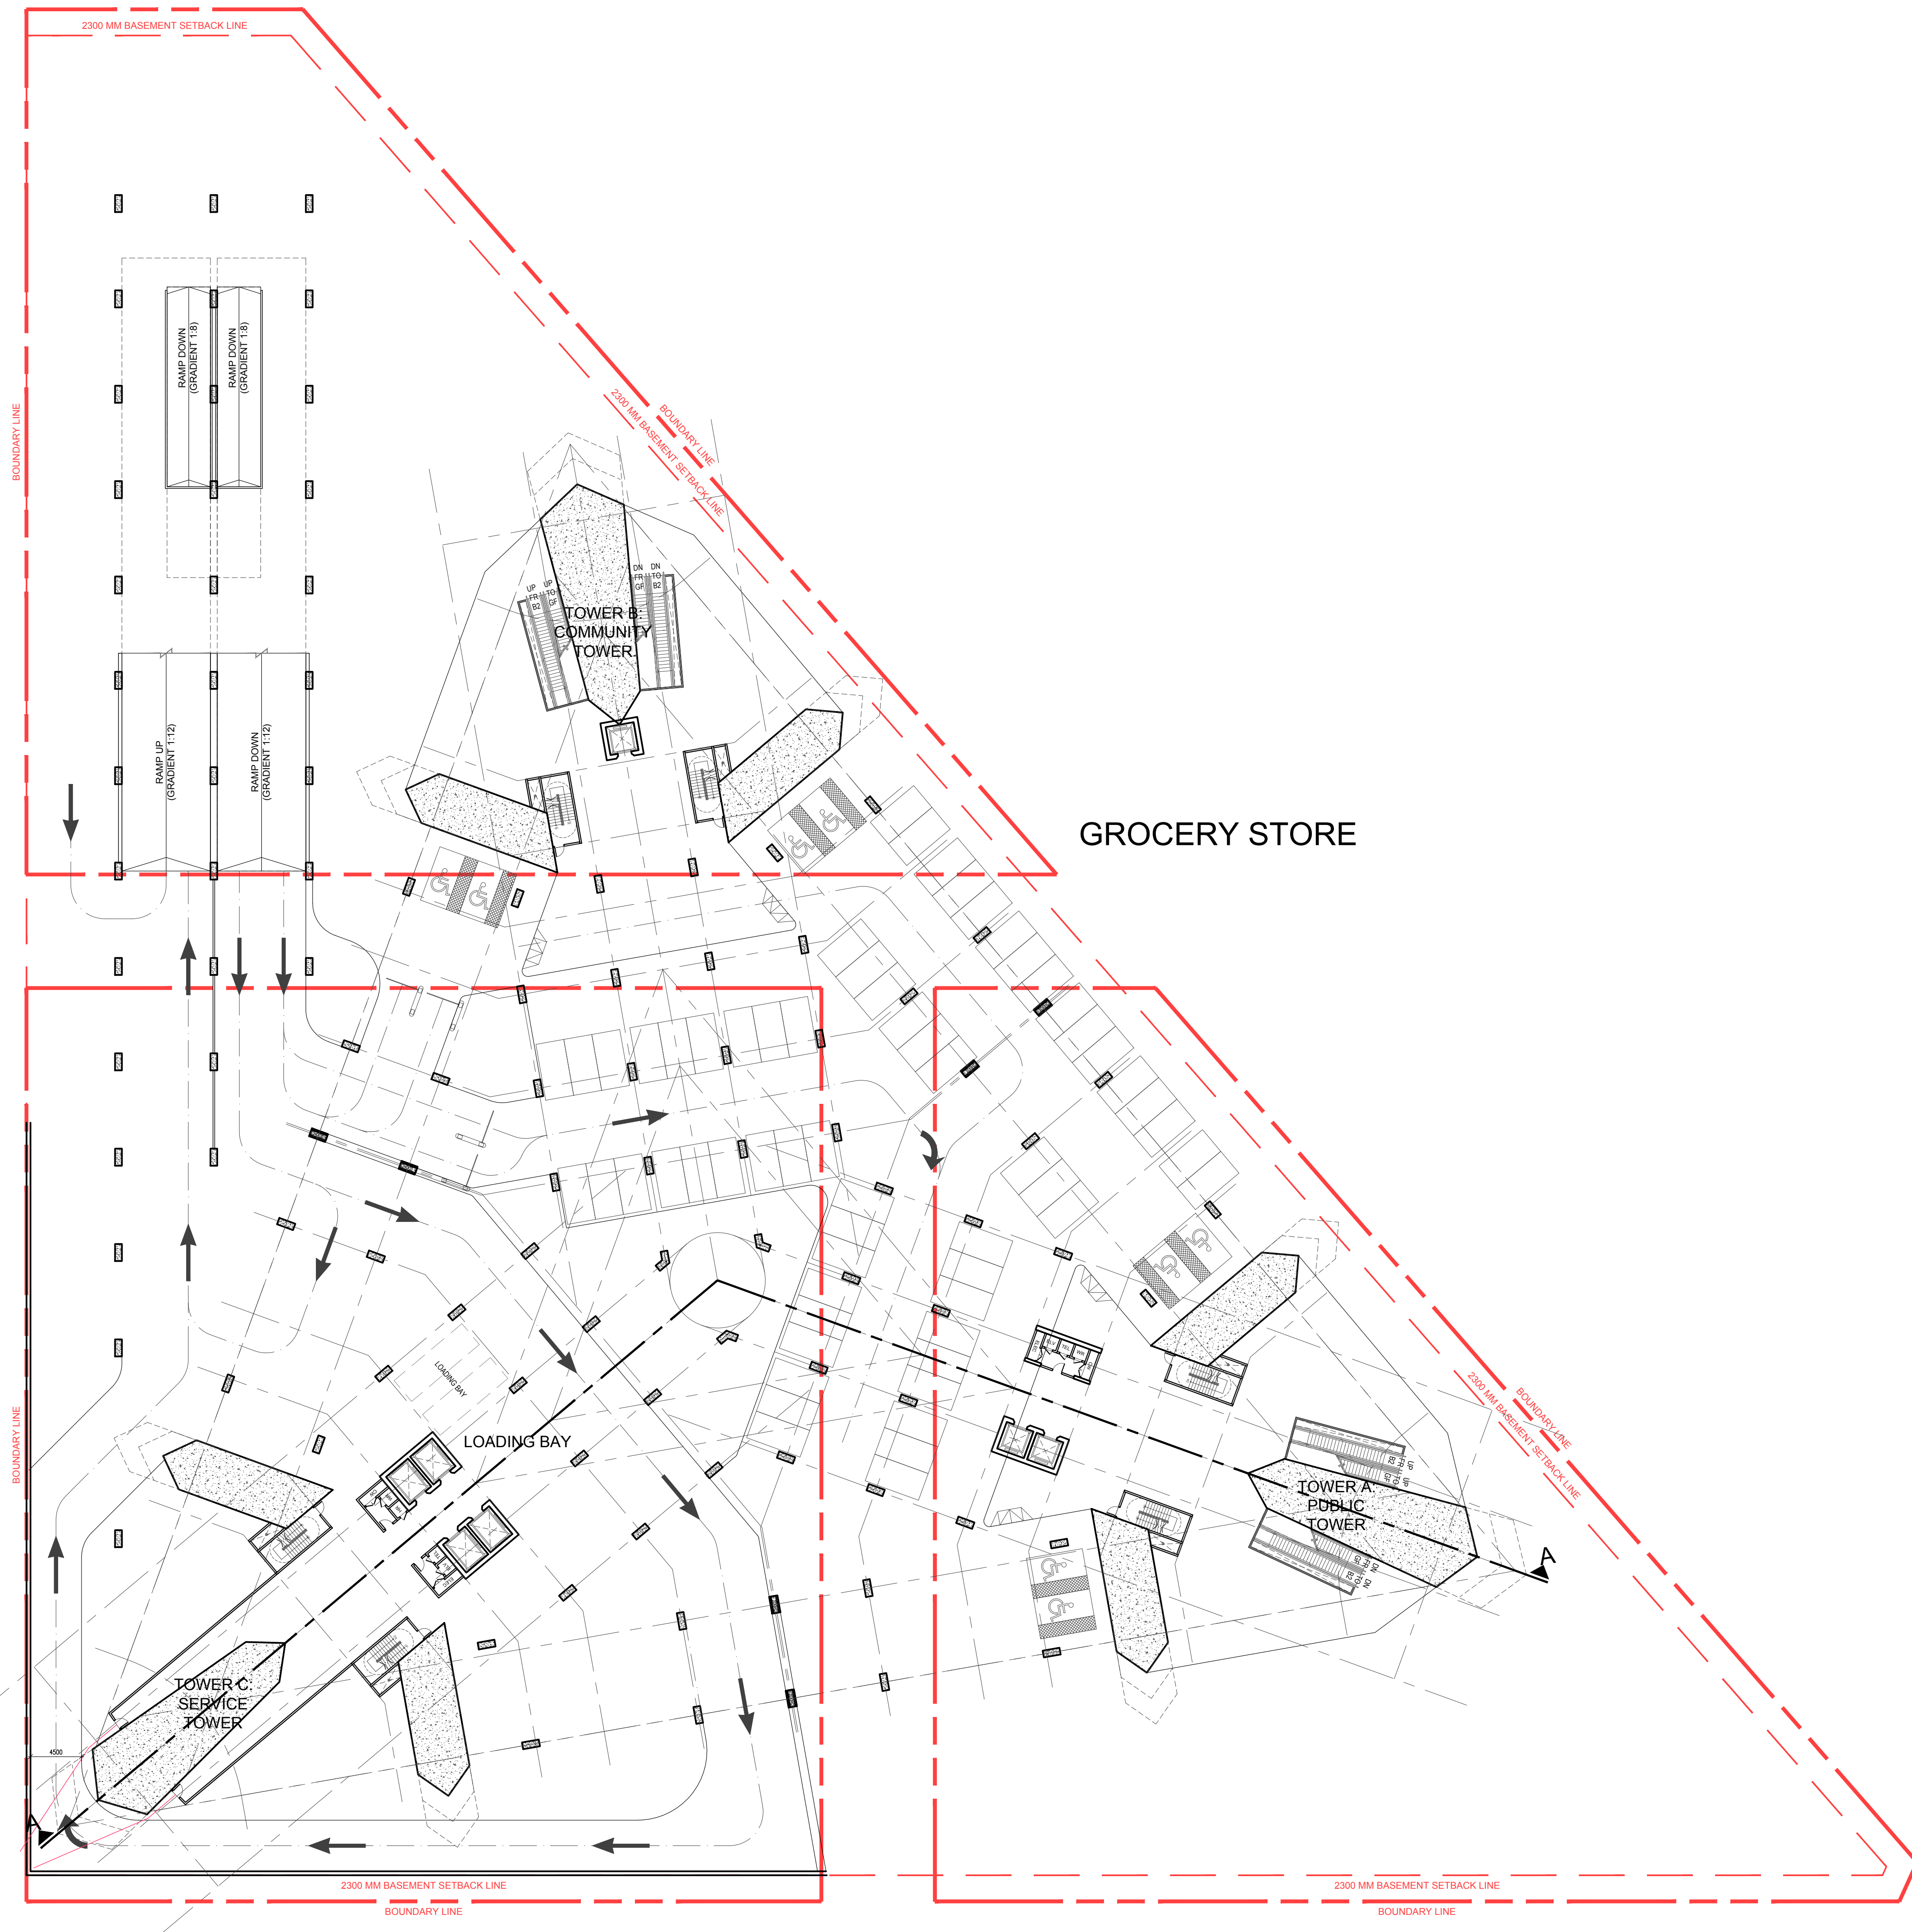

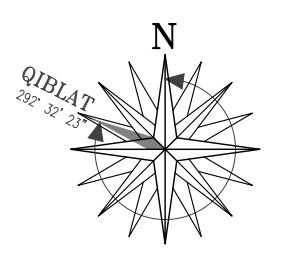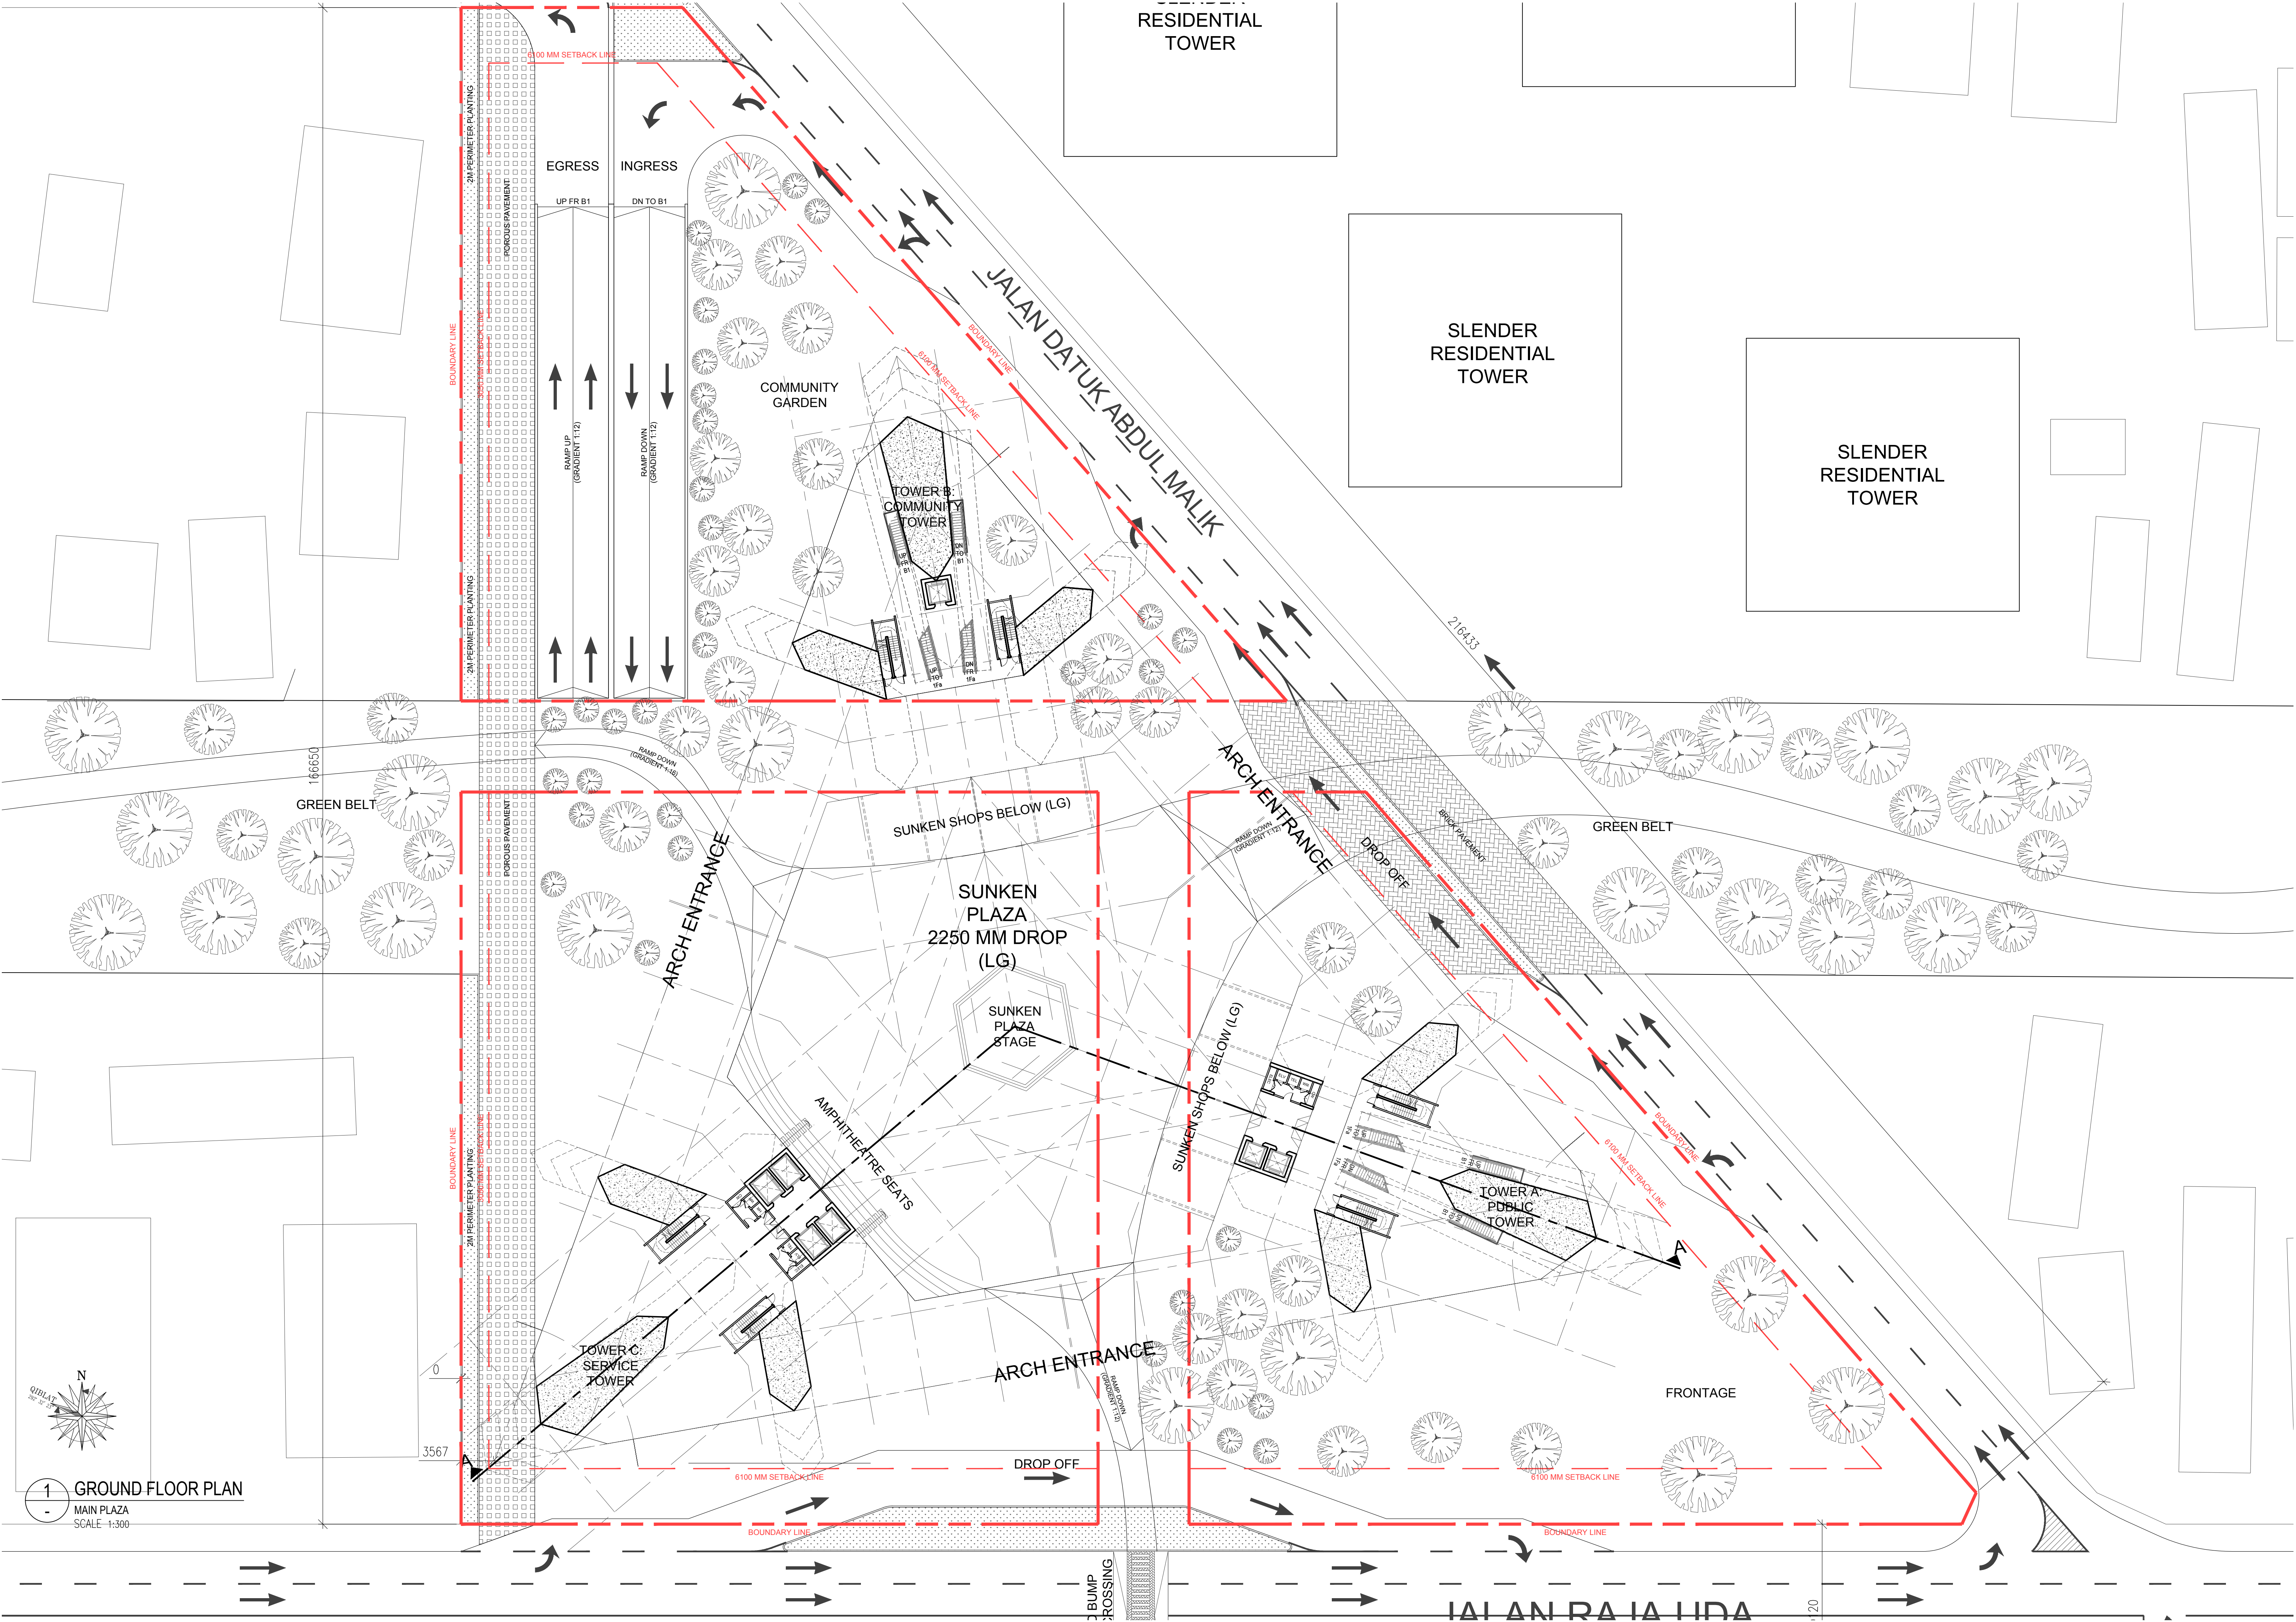

1 GROUND FLOOR PLAN
MAIN PLAZA
SCALE 1:300

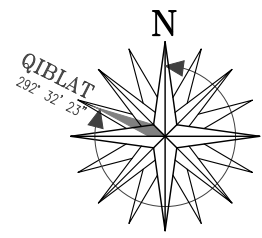

1 1ST FLOOR PLAN
- MAIN ELEVATOR HUB
SCALE 1:200

